

<u>BNPM/NCB/</u> <u>CR/1010/2020-21</u> <u>dated 20.01.2021</u>	BANK NOTE PAPER MILL INDIA PRIVATE LIMITED	Cover Sheet
	<u>RENOVATION WORK OF STAFF CANTEEN, BNPM</u> <u>PREMISES, MYSURU</u> Corrigendum 1	SHEET 1 OF 4

CORRIGENDUM NO. 1 DATED 05.02.2021

FOR

BNPM/NCB/ CR/1010/2020-21 dated 20.01.2021

FOR

Renovation work of Staff Canteen, BNPM premises, Mysuru.

PURCHASER : BANK NOTE PAPER MILL INDIA PRIVATE LIMITED

LOCATION : MYSORE, KARNATAKA

<u>BNPM/NCB/ CR/1010/2020-21 dated 20.01.2021</u>	BANK NOTE PAPER MILL INDIA PRIVATE LIMITED	Cover Sheet
	<u>RENOVATION WORK OF STAFF CANTEEN, BNPM PREMISES, MYSURU</u> Corrigendum 1	SHEET 2 OF 4

1.0 SCOPE OF THIS CORRIGENDUM

1. This corrigendum is issued to incorporate revision made in tender for Renovation work of Staff Canteen, BNPM premises, Mysuru. Details provided in this corrigendum shall override or clarifications those mentioned in the e-tender BNPM/NCB/ CR/1010/2020-21 dated 20.01.2021.
2. Except for details mentioned herein, all other details contained in the e-tender BNPM/NCB/ CR/1010/2020-21 dated 20.01.2021 shall remain unchanged.
3. Revision of Date and Time of Submission of Bid: **NO CHANGE**

Last date for submission of
tender:

1500 Hours on Feb 19,
2021.

<u>BNPM/NCB/ CR/1010/2020-21 dated 20.01.2021</u>	BANK NOTE PAPER MILL INDIA PRIVATE LIMITED	Cover Sheet
	<u>RENOVATION WORK OF STAFF CANTEEN, BNPM PREMISES, MYSURU</u> Corrigendum 1	SHEET 3 OF 4

**Tender Document for Renovation work of Staff Canteen, BNPM premises,
Mysuru.**

e-Tender No. BNPM/NCB/ CR/1010/2020-21 dated 20.01.2021.

Pre-Bid meeting held on 03.02.2021 at Conference room in Administrative Building, BNPM, Mysuru.

<i>Sl. No.</i>	<i>Query submitted / clarifications sought by bidder</i>	<i>BNPM reply</i>
1	Basic price required for Sanitary and CP Fittings, Vitrified Tiles, Glazed Tiles and Granite.	Refer Annexure-1. Basic rates for Loose furniture are also provided. (Page no.1 of 8). Please note that the difference amount shall be payable or recoverable as the case may be which is based on production of original invoice/s, if the selected material works out to more or less than the basic rate mentioned in Annexure-1. The basic rate considered are exclusive of taxes.
2	Pergola Design Image or Sketch Required (3D)	Refer Annexure-1. Detailed Drawing enclosed (Page no.2 of 8)
3	Kindly let us know the allowed working hours and will the labour get monthly pass for entry?	Normal working hours 9 AM to 6 PM. Permission for holiday and late night working may be provided as per requirement with approval of competent authority.
4	Is the police verification of all labours required?	YES. As per BNPM security policy. Refer tender clause under Section V-SCC, 12 (xii) page no. 33 of 60.
5	We require Loose furniture like bar stools, tables, chairs, sofa basic price, images and design.	Refer Annexure-1. (Page no. 5 of 8, 6 of 8 & 7 of 8)




<u>BNPM/NCB/ CR/1010/2020-21 dated 20.01.2021</u>	BANK NOTE PAPER MILL INDIA PRIVATE LIMITED	Cover Sheet
	<u>RENOVATION WORK OF STAFF CANTEEN, BNPM PREMISES, MYSURU</u> Corrigendum 1	SHEET 4 OF 4


6	Awning Design Required	Refer Annexure-1. (Page no.8 of 8)
7	HVAC Drawing Required	Refer Annexure-1. (Page no. 3 of 8 & 4 of 8)
8	Whether handing over of site will be phase wise and if phase wise which area will be given first?	One time Handing over
9	Approval for Equivalent/alternate approved makes on Aluminium sections & drawings required	As per tender
10	Material movement process	All material movement through material gate. Working time hours 9 AM to 6 PM. General holidays and Sundays not allowed. Valid documents pertaining to Vehicle and driver shall be submitted.
11	Running bill time period	Minimum 30 days. After submission of all relevant documents and compliances

Basic Material Rate



Sl. no	Description	Unit	Basic Rate	Image	Remark
1	Vitrified Tiles - 600X600 mm	Sqmt	406.78		
2	Colour glazed tiles 15x15 cms 6mm thick	Sqmt	301.33		
3	Granite 20 mm thick	Sqmt	1266.95		
	SANITARY & CP FIXTURES.				
4	Water closet European type	Each	978.81		
5	Urinal basin	Each	610.17		
6	Wash basin	Each	779.66		
7	Stainless steel kitchen sink	Each	4004.24		
8	C.P.brass pillar tap elbow operated	Each	415.25		
	LOOSE FURNIURES				
9	Bar Counter (SS LEG & table top with approved top Granite finish including round nosing).	Sqmt	6800		Detailed drawing has shared
10	Round Table 900mm dia x 750mm (H)	Sqmt	6800		
11	Bench Seating - 3037mm (W) x 400mm (D) x 750mm (H)	Rmt	12500		
12	Bar stool	Each	4620		
12	Awning (Manual retractable - Fabric cladded - Al. framed)	Sqmt	7100		

Note:**Canteen Chairs & Table - Existing to be Retained**

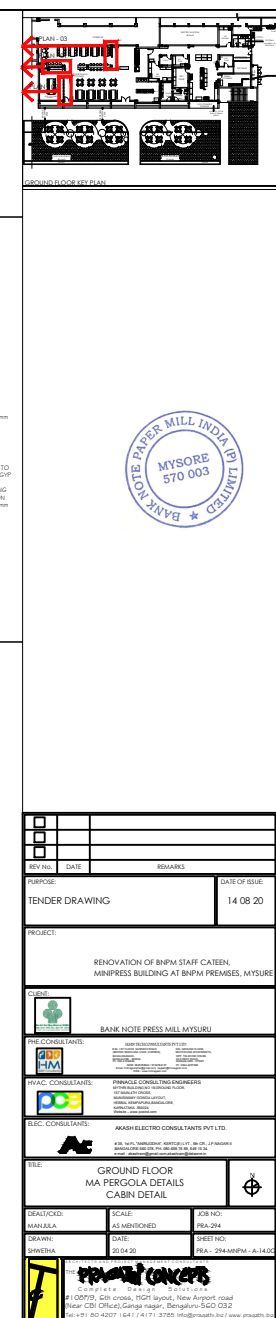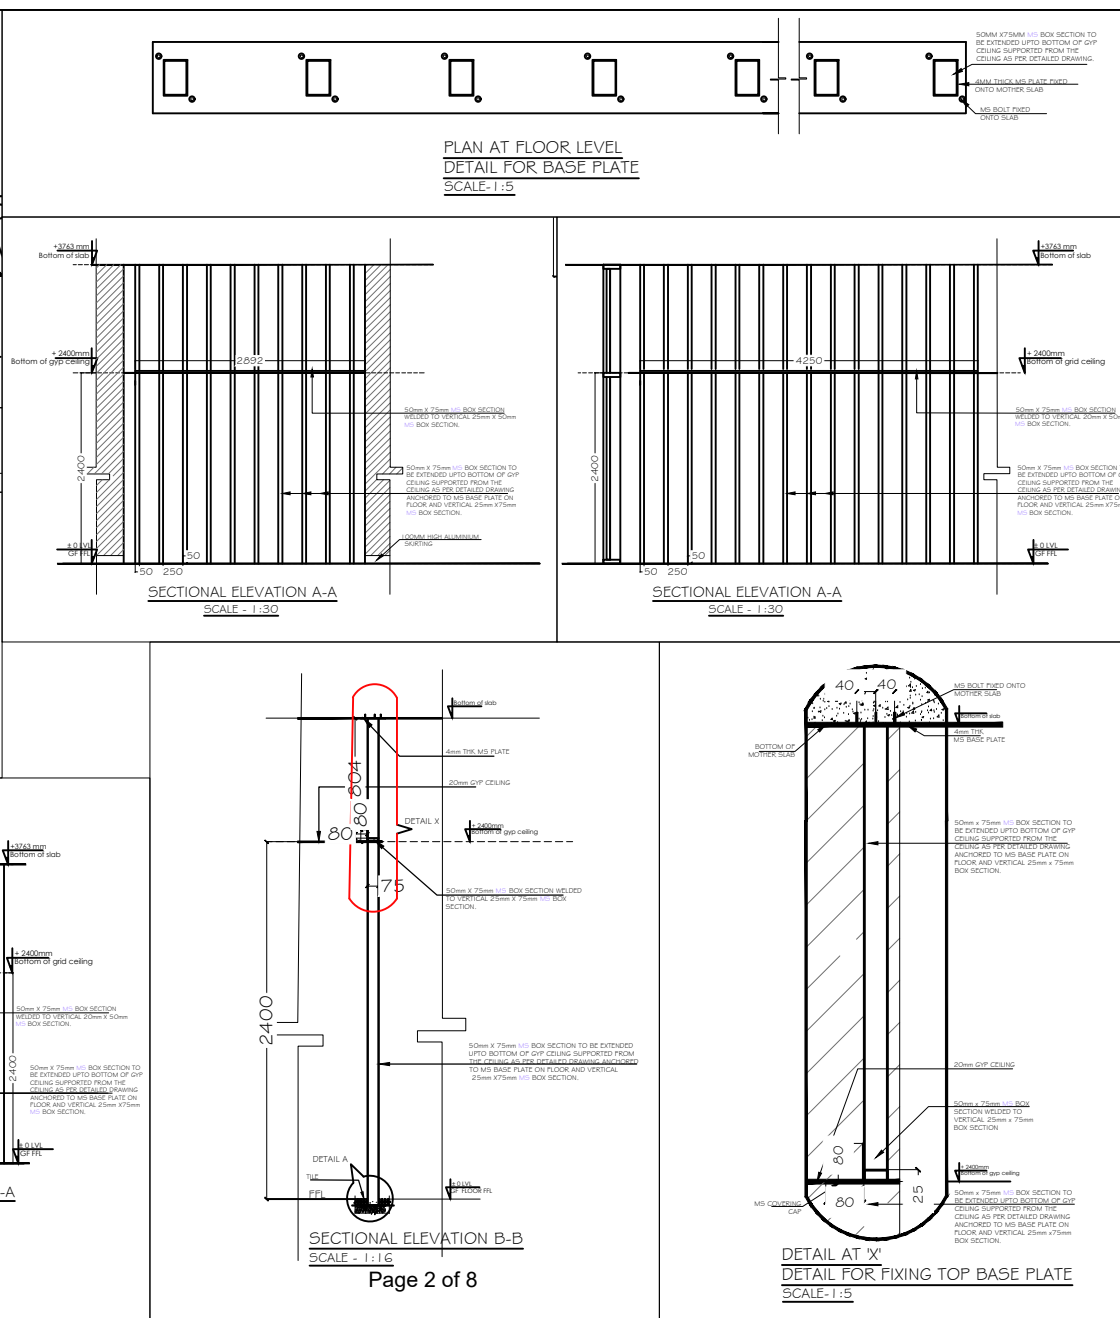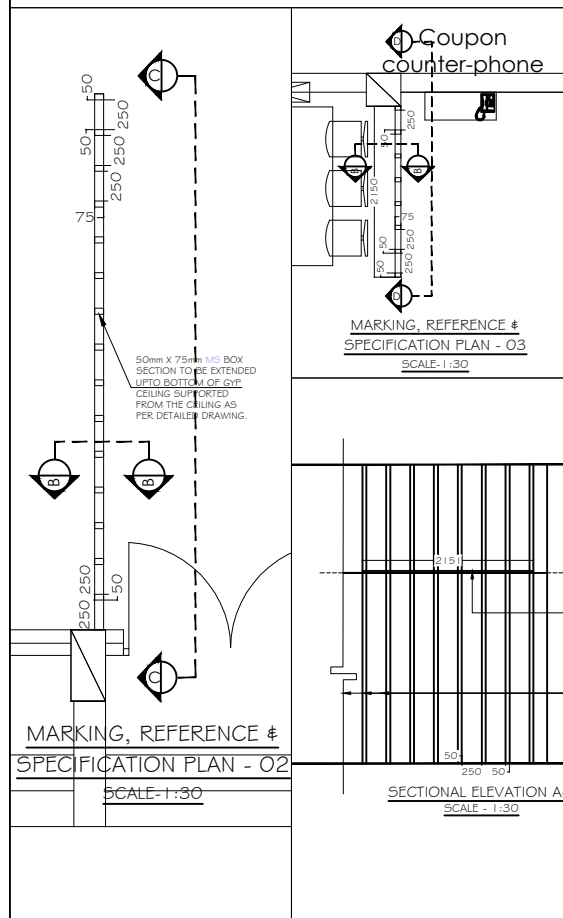

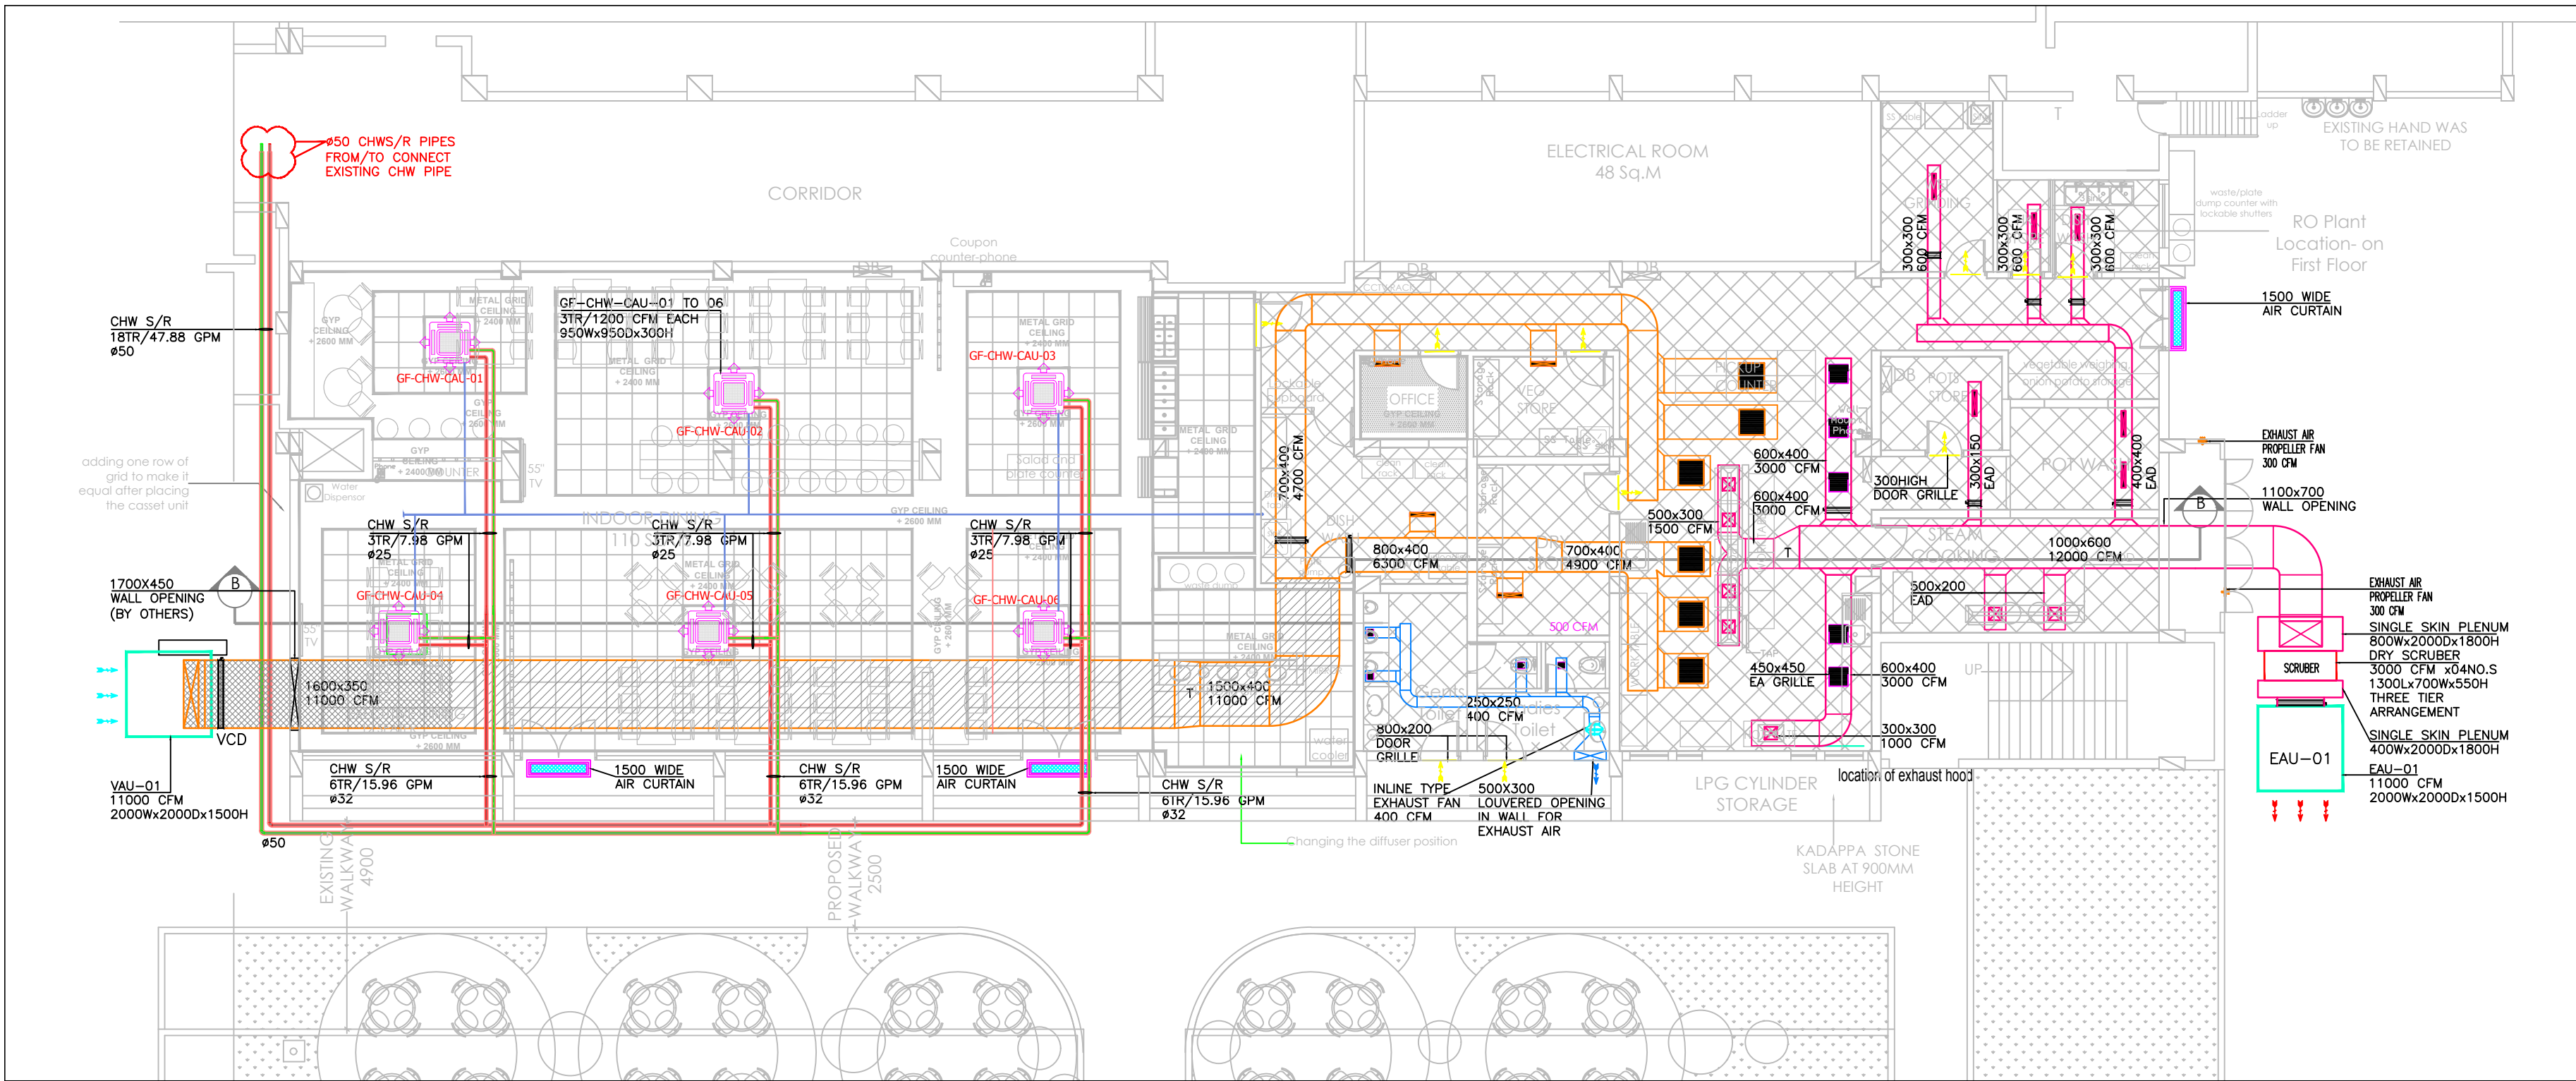

PROPOSED HVAC-LEGEND/SYMBOLS:-	
	SUPPLY AIR RECTANGULAR DUCT
	FRESH AIR RECTANGULAR DUCT
	TOILET EXHAUST AIR RECTANGULAR DUCT
	EXHAUST AIR RECTANGULAR DUCT
	15 mm THICK ACOUSTIC INSULATION(INSIDE THE DUCT)
	10 MM THICK THERMAL INSULATION(OUTSIDE THE DUCT)
	VOLUME CONTROL DAMPER
	600X600 SQAURE GRILLE FOR FRESH AIR/EXHAUST AIR
	150X150MM DIA EXHAUST GRILLE
	1500MM DIA WIDE AIR CURTAIN
	CHILLED WATER SUPPLY PIPE WITH INSULATION
	CHILLED WATER RETUN PIPE WITH INSULATION
	DRAIN PIPE
	CHILLED WATER CASSETTE UNIT
	DRY SCRUBBER
	FLOOR MOUNTED VENTILATION AIR UNIT
	FLOOR MOUNTED EXHAUST AIR UNIT
	CIRCULAR INLINE EXHAUST AIR FAN
	PROPELLER EXHAUST AIR FAN
	DOOR GRILLE

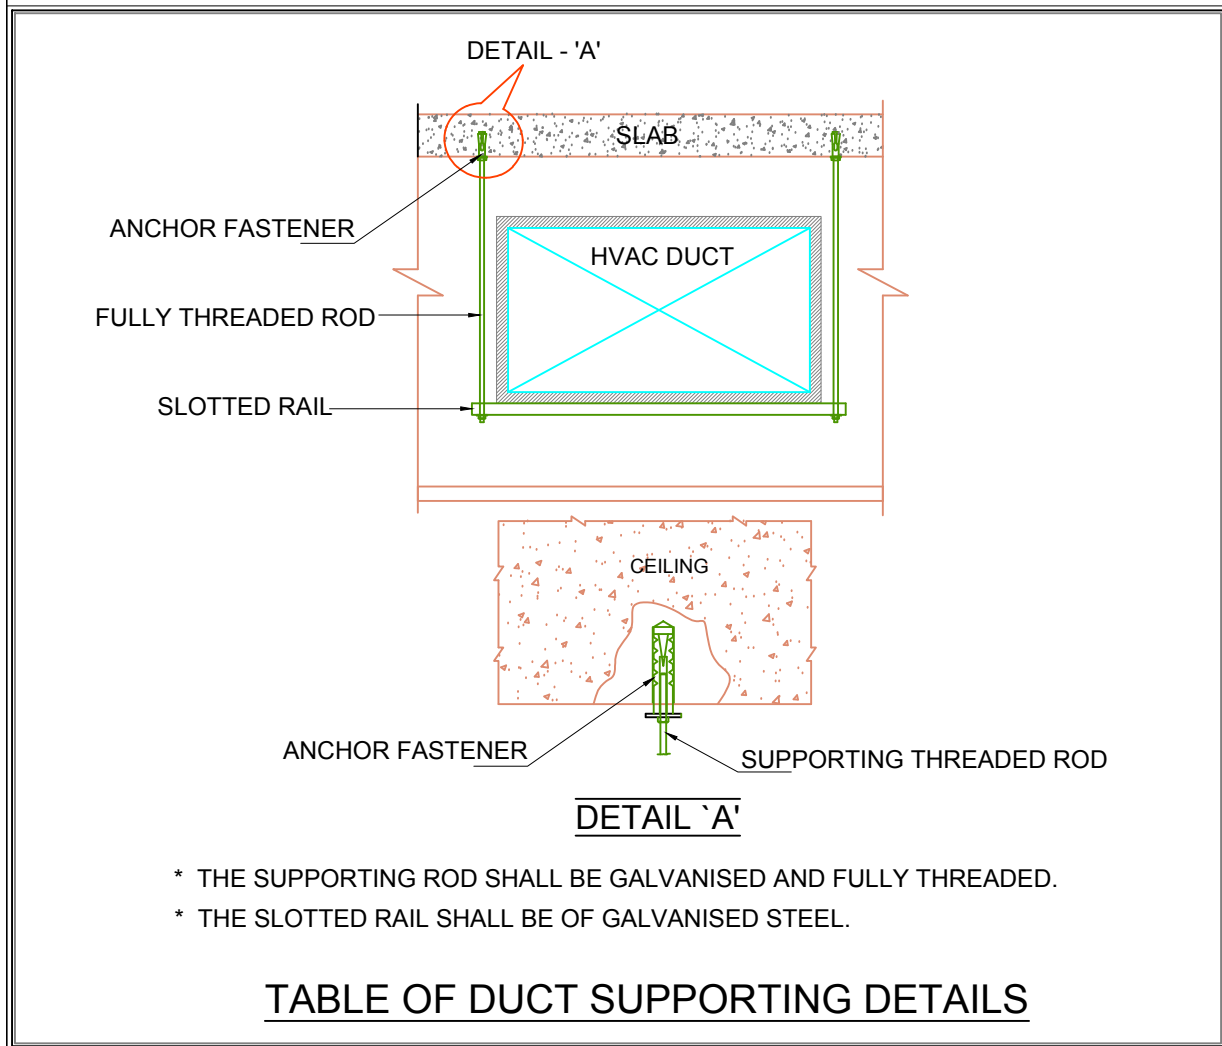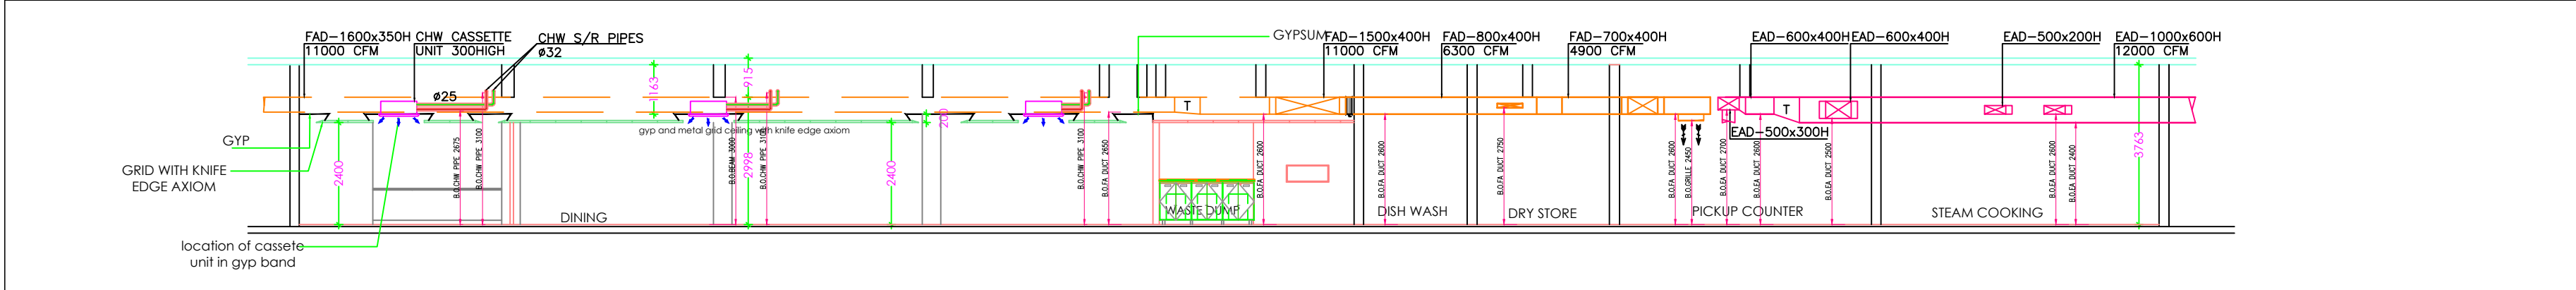

SCHEDULE OF GSS DUCT












DUCT SIZE IN mm	SHEET GAUGE	TRANSVERSE JOINT	SPACING SUPPORT
UP TO 750mm	24 G	TDC/TDF FLANGES	2400mm
751 TO 1500mm	22 G	TDC/TDF FLANGES	2400mm
1500 TO 2250mm	22 G	TDC/TDF FLANGES	2400mm
2250 & ABOVE	18 G	TDC/TDF FLANGES	2000mm

HVAC NOTES:

1. TERMINATION OF DRAIN POINT WILL BE AS PER SITE CONDITION.
2. ALL CLOSED ROOMS PARTITION TO BE RAISED ABOVE FALSE CEILING UNTIL & UNLESS INDICATED IN DRAWING.
3. DUCT ELBOW WIDTH ABOVE 700MM TO BE PROVIDED WITH GUIDE VANES FOR ALL DUCTS.
4. DUCT WIDTH ABOVE 1200MM TO BE PROVIDED WITH TIE RODS.
5. DUCT WIDTH ABOVE 900MM TO BE PROVIDED WITH M.S ANGLE SUPPORT INSTEAD OF SLOTTED CHANNEL SUPPORT.
6. DRAIN PUMPS TO BE PROVIDED WITH UPS POWER.
7. TO ACHIEVE BOTTOM OF DUCT, SPRINKLER LINE TO BE CHANGED WHEREVER RQUIRED AS PER SITE CONDITON.
8. WHEREVER DUCT RUNNING BELOW BEAM TO AVOID FLANGE.
9. THE CHILLED WATER INLET TEMPERATURE SHOULD NOT BE MORE THAN 7°C IN ORDER TO ATTAIN THE TEMPERATURE OF 23°C INSIDED THE OFFICE AREAS.
10. THE CHILLED WATER INLET PRESSURE SHOULD NOT BE MORE THAN 3kg/cm².



☐	☐	☐	☐
☐	☐	☐	☐
☐	☐	☐	☐
☐	☐	☐	☐
REV No.	DATE	REMARKS	
PURPOSE:		DATE OF ISSUE:	
TENDER DRAWINGS		8 08 2020	
PROJECT:			
RENOVATION OF BNPM STAFF CANTEEN, MINIPRESS BUILDING AT BNPM PREMISES, MYSURU			
CLIENT:			
BANK NOTE PRESS MILL, MYSURU			
PHE CONSULTANTS:			
HVN TECHCONSULTANTS PVT LTD.			
HVAC CONSULTANTS:			
PINNACLE CONSULTING ENGINEERS			
ELEC. CONSULTANTS:			
AKASH ELECTRO CONSULTANTS PVT LTD.			
TITLE:		HVAC LAYOUT	
DEALT/CKD:	SCALE:	JOB NO:	
BANERJEE	AS MENTIONED	PCE-HVAC-004	
DRAWN:	DATE:	SHEET NO:	
GAJENDRA	17 07 2020	PCE-HVAC-004-01	
THE PRAGATHI CONCEPTS Complete Design Solutions #108/F/9, 6th cross, HGH layout, New Airport road (Near CBI Office), Ganga nagar, Bengaluru-560 032 Tel:+91 80 4207 1641 / 4171 3785 Info@pragathi.biz / www.pragathi.biz			

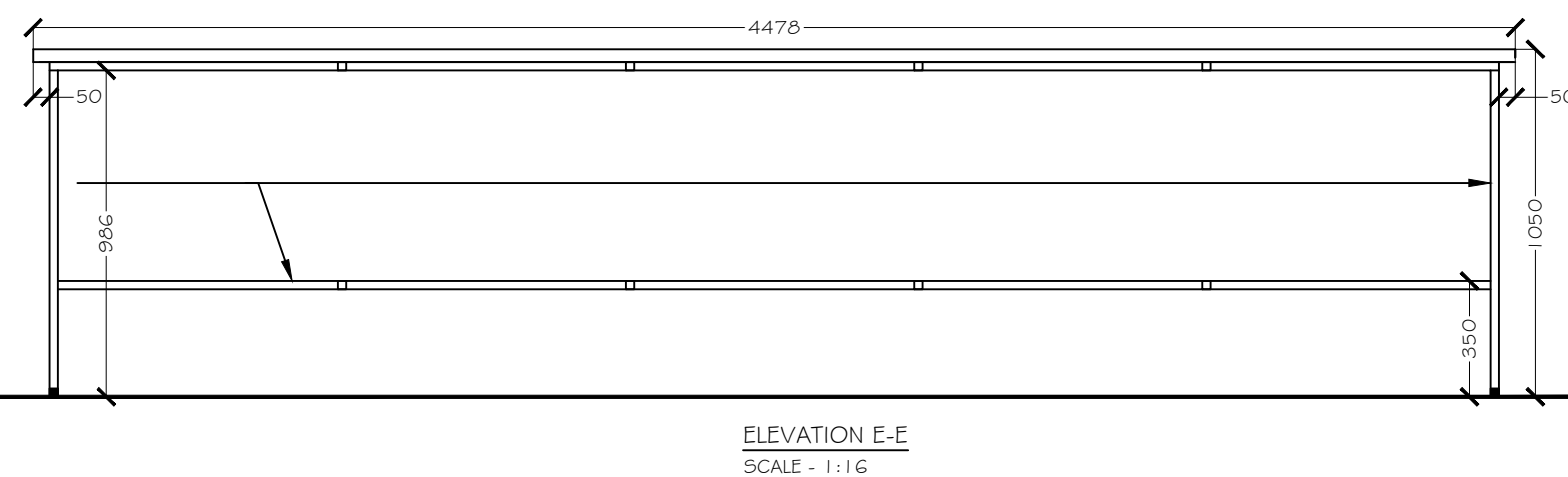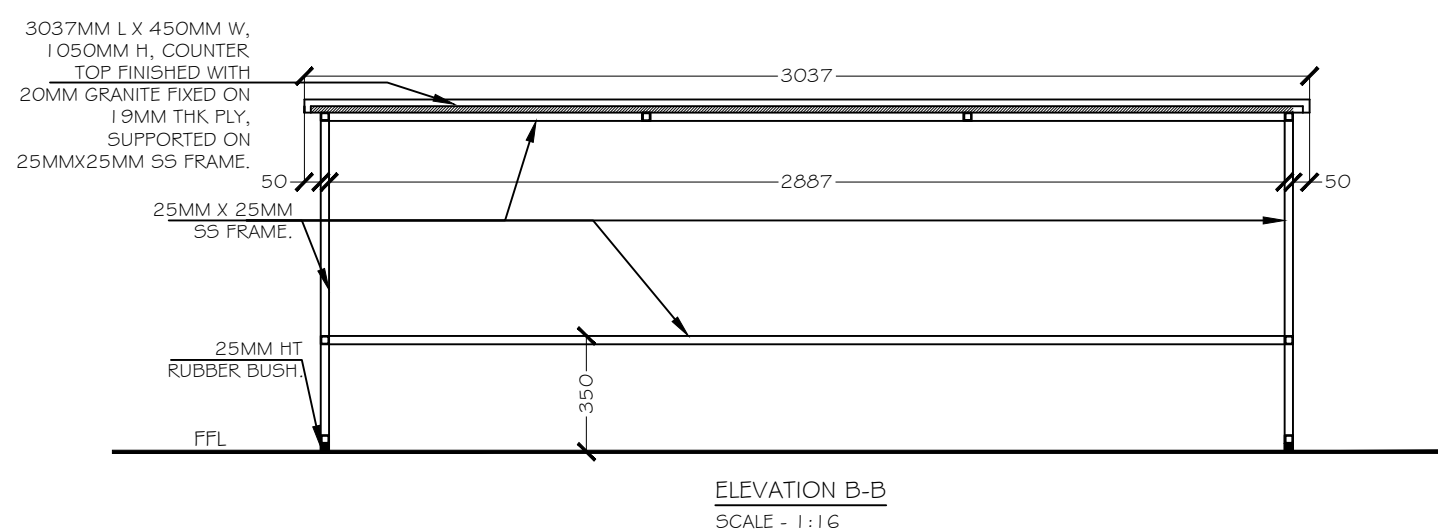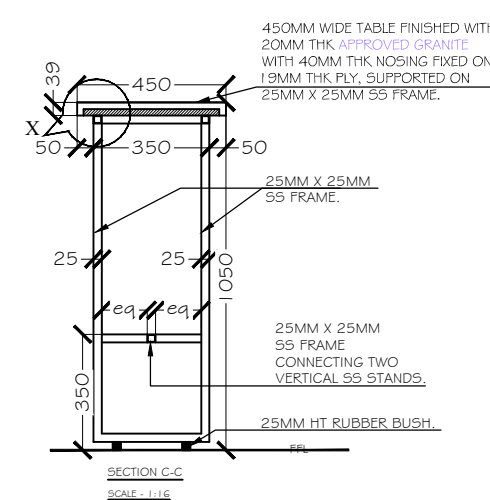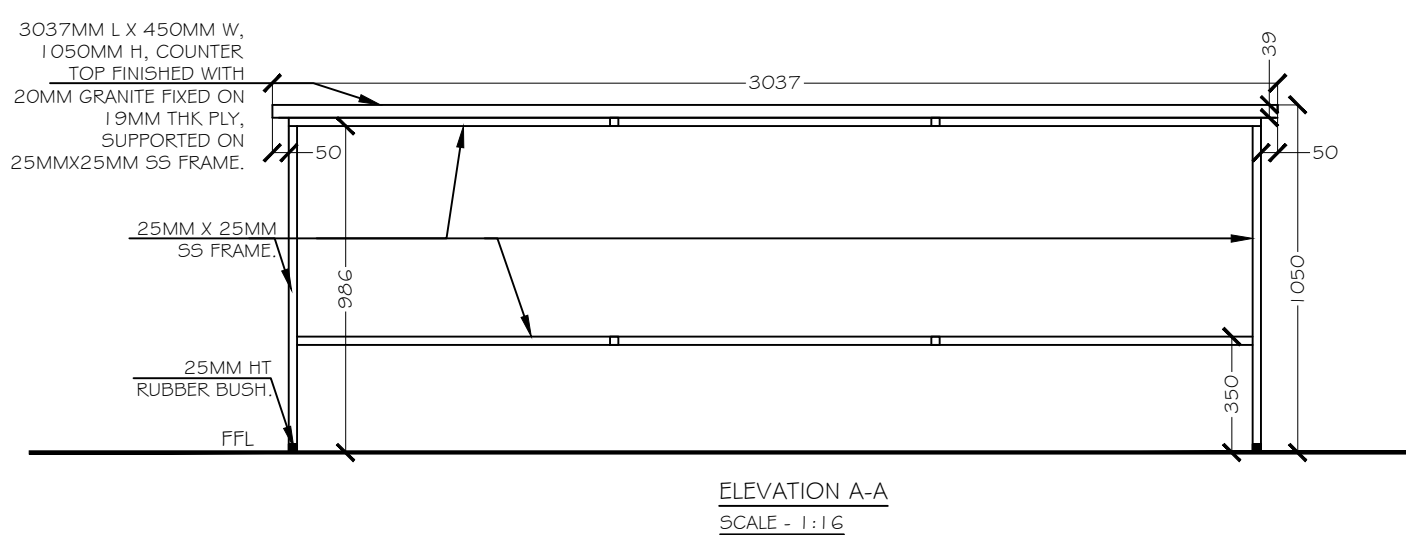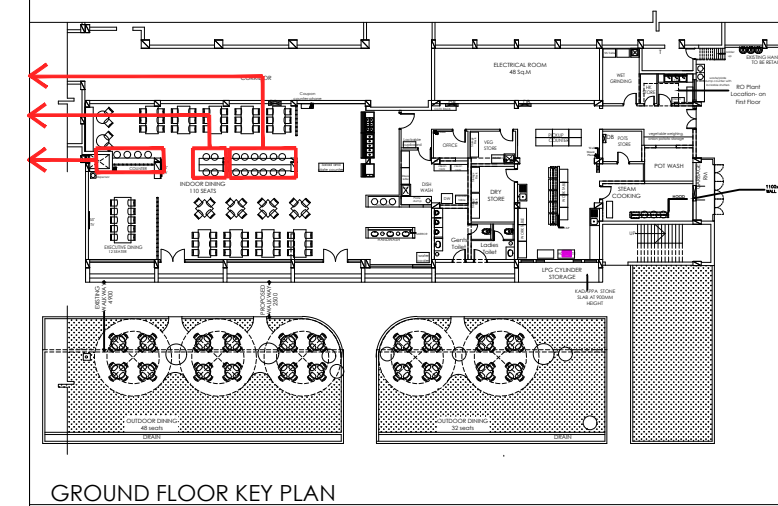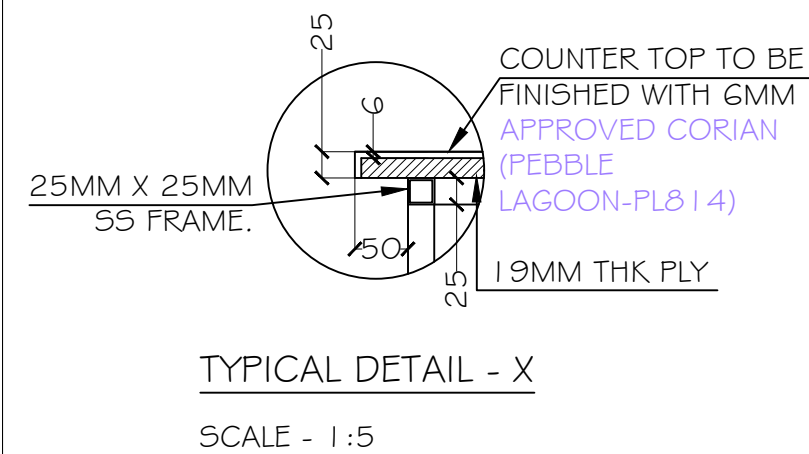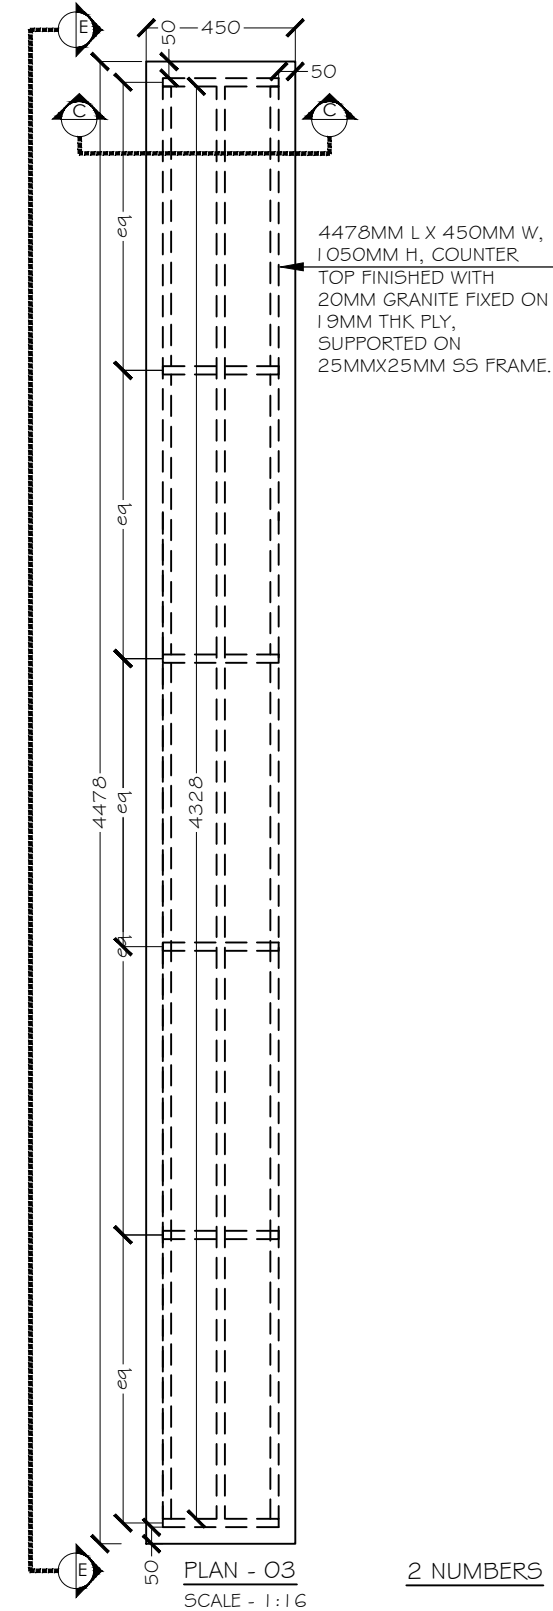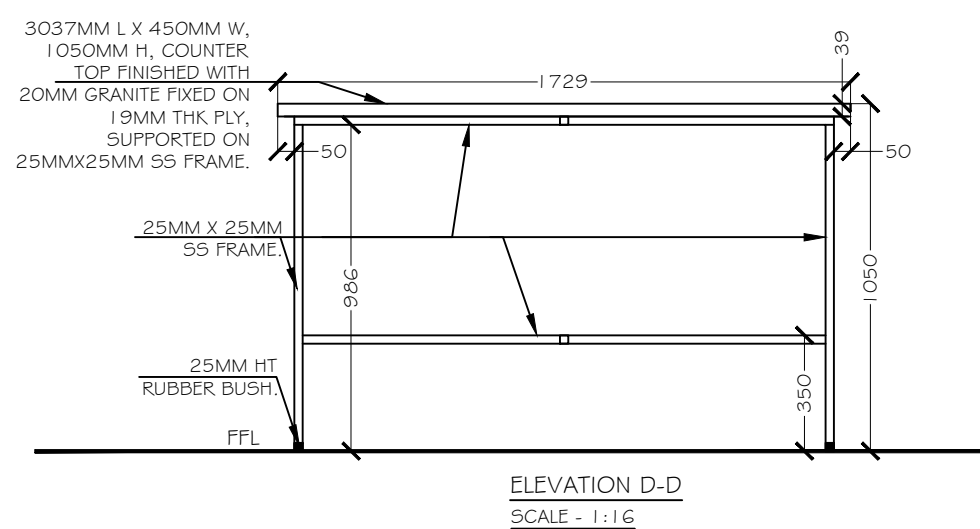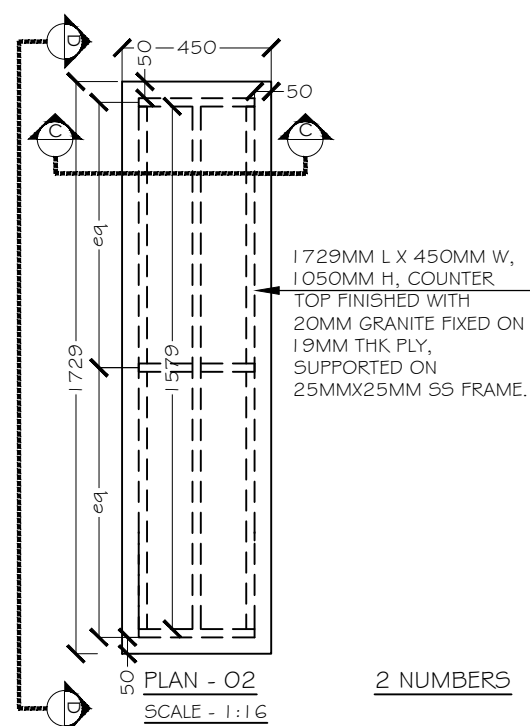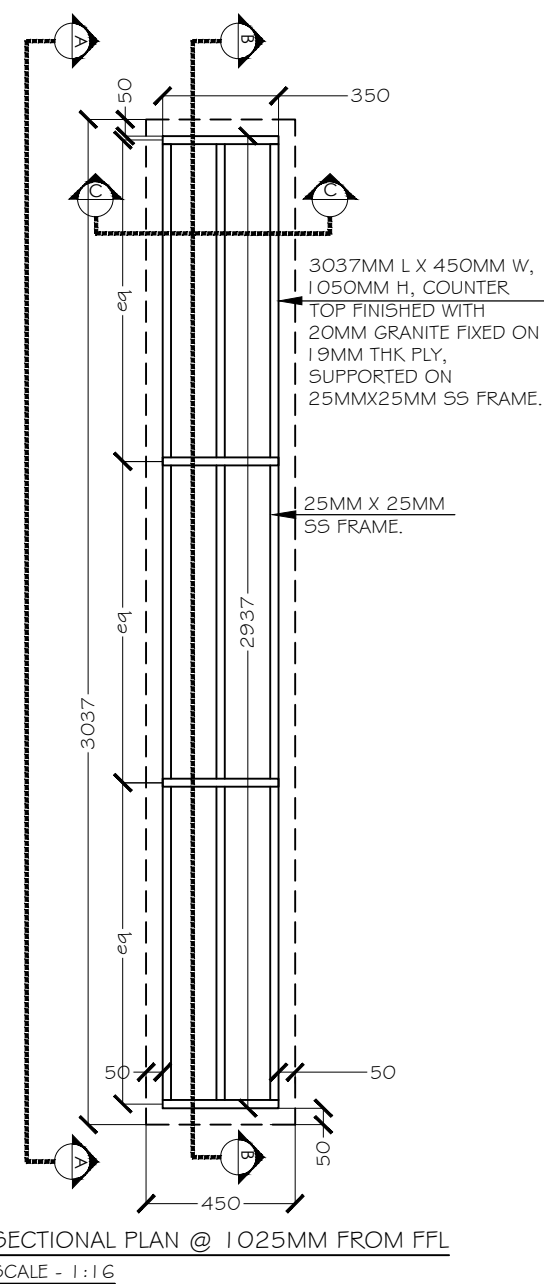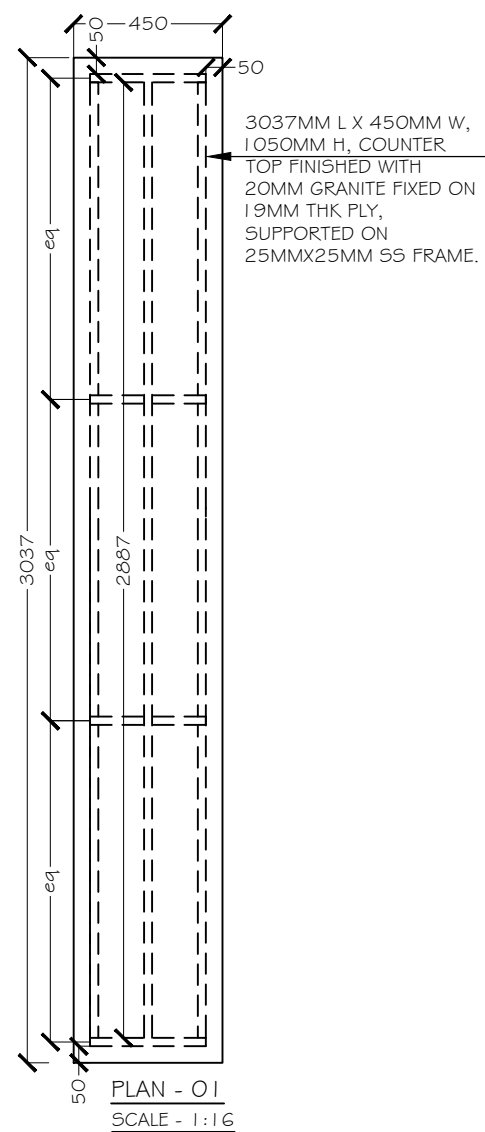

☐	☐	☐	☐
☐	☐	☐	☐
☐	☐	☐	☐
REV No.	DATE	REMARKS	
PURPOSE: TENDER DRAWING			DATE OF ISSUE: 14 08 20
PROJECT:			
RENOVATION OF BNPM STAFF CATEEN, MINIPRESS BUILDING AT BNPM PREMISES, MYSURE			
CLIENT:			
 BANK NOTE PRESS MILL, MYSURU			
PHE CONSULTANTS:  NEW TOWER CONSULTANTS PVT LTD 404/405, 4TH FLOOR, COMPLEX BANGALORE-560 002 TEL: 080-26000000 FAX: 080-26000001 WWW.PHECONSULTANTS.COM			
HVAC CONSULTANTS:  PRINACLES CONSULTING ENGINEERS MYRATH BUILDING 1ST FLOOR & FLOOR 1ST MAIN BETH CROSS NEAR MURRAY GOWD LAYOUT HOSUR, KARNATAKA, KARNATAKA KARNATAKA, 560024 Mysuru : www.pceindia.com			
ELEC CONSULTANTS: AKASH ELECTRO CONSULTANTS PVT LTD.  # 35, 16 FL "ANANDRASHA" KSRITECH LYT. SR. CR., J.P. NAGAR-II BANGALORE-560 016 TEL: 080-499 78 86, 98 48 14 e-mail: akashelc@gmail.com-akashelc@gmail.com			
TITLE:			
BAR COUNTER DETAIL			
DEALT/CKD: MANJULA	SCALE: AS MENTIONED	JOB NO: PRA-294	
DRAWN: SHWETHA	DATE: 29 04 20	SHEET NO: PRA-294-MNPM - A-14.0G	
 ARCHITECTS AND PROJECT MANAGEMENT CONSULTANTS THE PRAGATHI CONCEPTS Complete Design Solutions #100/79, 6th cross, HGH layout, New Airport road (Near CBI Office) Ganga nagar, Bengaluru-560 032 Tel: +91 80 4207 1641 / 4171 3785 Email: pragathi.biz / www.pragathi.biz			

